
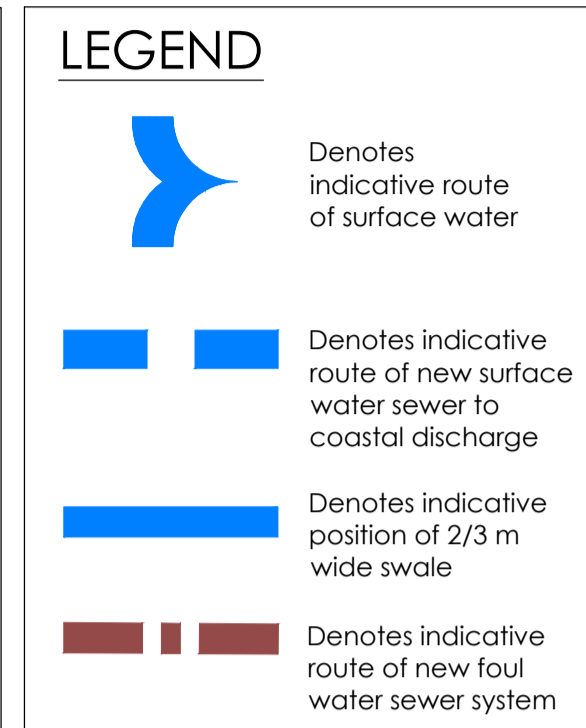


DO NOT SCALE FROM THIS DRAWING.
WORK TO FIGURED DIMENSION ONLY.

- NOTES**
- All DNA drawings are to be read in conjunction with the relevant DNA Specification and all relevant Architects and Service Engineer's drawings and Specifications.
 - All dimensions and setting out to be confirmed by the Architect.

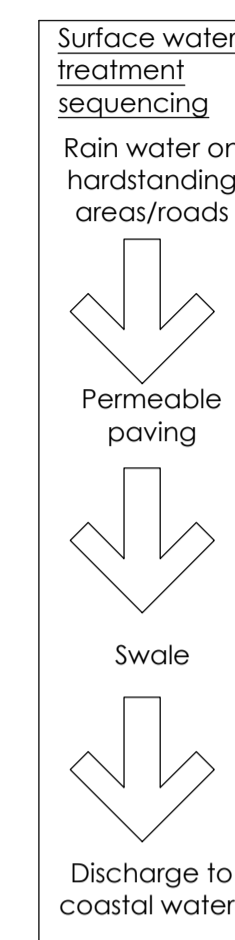

A	Drawing updated to suit new layout.	RT	GM	15.02.19
-	Drawing issued for INFORMATION.	RT	NB	03.10.18
Rev	Description	Chk	Drm	Date

Status
INFORMATION

david narro associates
Consulting Structural & Civil Engineers

- 34-36 Argyle Place, Edinburgh, EH9 1JT
T 0131 229 5533
 - 24 James Morrison Street, Glasgow, G1 5PE
T 0141 552 4080
 - Flinton Scotland, The Enterprise Park, Forres, Moray, IV36 2AB
T 0130 947 8135
 - 5 Viewfield Place, Stirling, FK8 1NQ
T 0179 644 9562
- W <http://www.davidnarro.co.uk> E mail@davidnarro.co.uk

Client
SHETLAND ISLANDS COUNCIL

Architect
7N ARCHITECTS

Job Title
THE KNAB, LERWICK

Sheet Title
INDICATIVE DRAINAGE LAYOUT

Drawn by NB	Designed KH	Approved RT
----------------	----------------	----------------

Scale 1:500 @ A1	Date 03.10.2018
---------------------	--------------------

Drawing number 17.0621-SK800	Revision A
--	----------------------

INDICATIVE DRAINAGE SCHEME
SCALE 1:500

